


LEGENDS :-

SYMBOL	DESCRIPTION
	AIR CIRCUIT BREAKER
	MOULDED CASE CIRCUIT BREAKER
	MINIATURE CIRCUIT BREAKER
	CAPACITOR BANK
	VACUUM CIRCUIT BREAKER
	PHASE INDICATION LAMP (LED TYPE)
	INDICATING LA (LED TYPE)
	TRIP CIRCUIT HEALTHY AUTO TRIP
	START/STOP PUSH BUTTON
	VOLTMETER
	AMMETER
	VOLTMETER SELECTOR SWITCH
	AMMETER SELECTOR SWITCH
	POWER TRANSFORMER
	CURRENT TRANSFORMER
	AUTOMATIC POWER FACTOR CORRECTION RELAY
	POWER FACTOR METER
	FREQUENCY METER
	KILO WATT HOUR METER
	POWER CONTACTOR
	TARIFF METER
	AMMETER WITH BUILT IN SELECTOR SWITCH
	MULTI FUNCTION METER
	CONTROL FUSE
	CHANGE OVER SWITCH
	AUTO TRANSFER SWITCH
	UNDER VOLTAGE RELAY WITH TIME DELAY
	OVER VOLTAGE RELAY WITH TIME DELAY
	REVERSE POWER RELAY
	MASTER TRIP/ LOCKOUT RELAY
	TRIP CIRCUIT SUPERVISION RELAY
	INSTANTANEOUS OVER CURRENT RELAY
	INSTANTANEOUS EARTH FAULT RELAY
	OVER CURRENT RELAY (IDMT)
	EARTH FAULT RELAY (IDMT)
	AUXILIARY RELAY
	ANTI PUMPING RELAY
	EARTHING

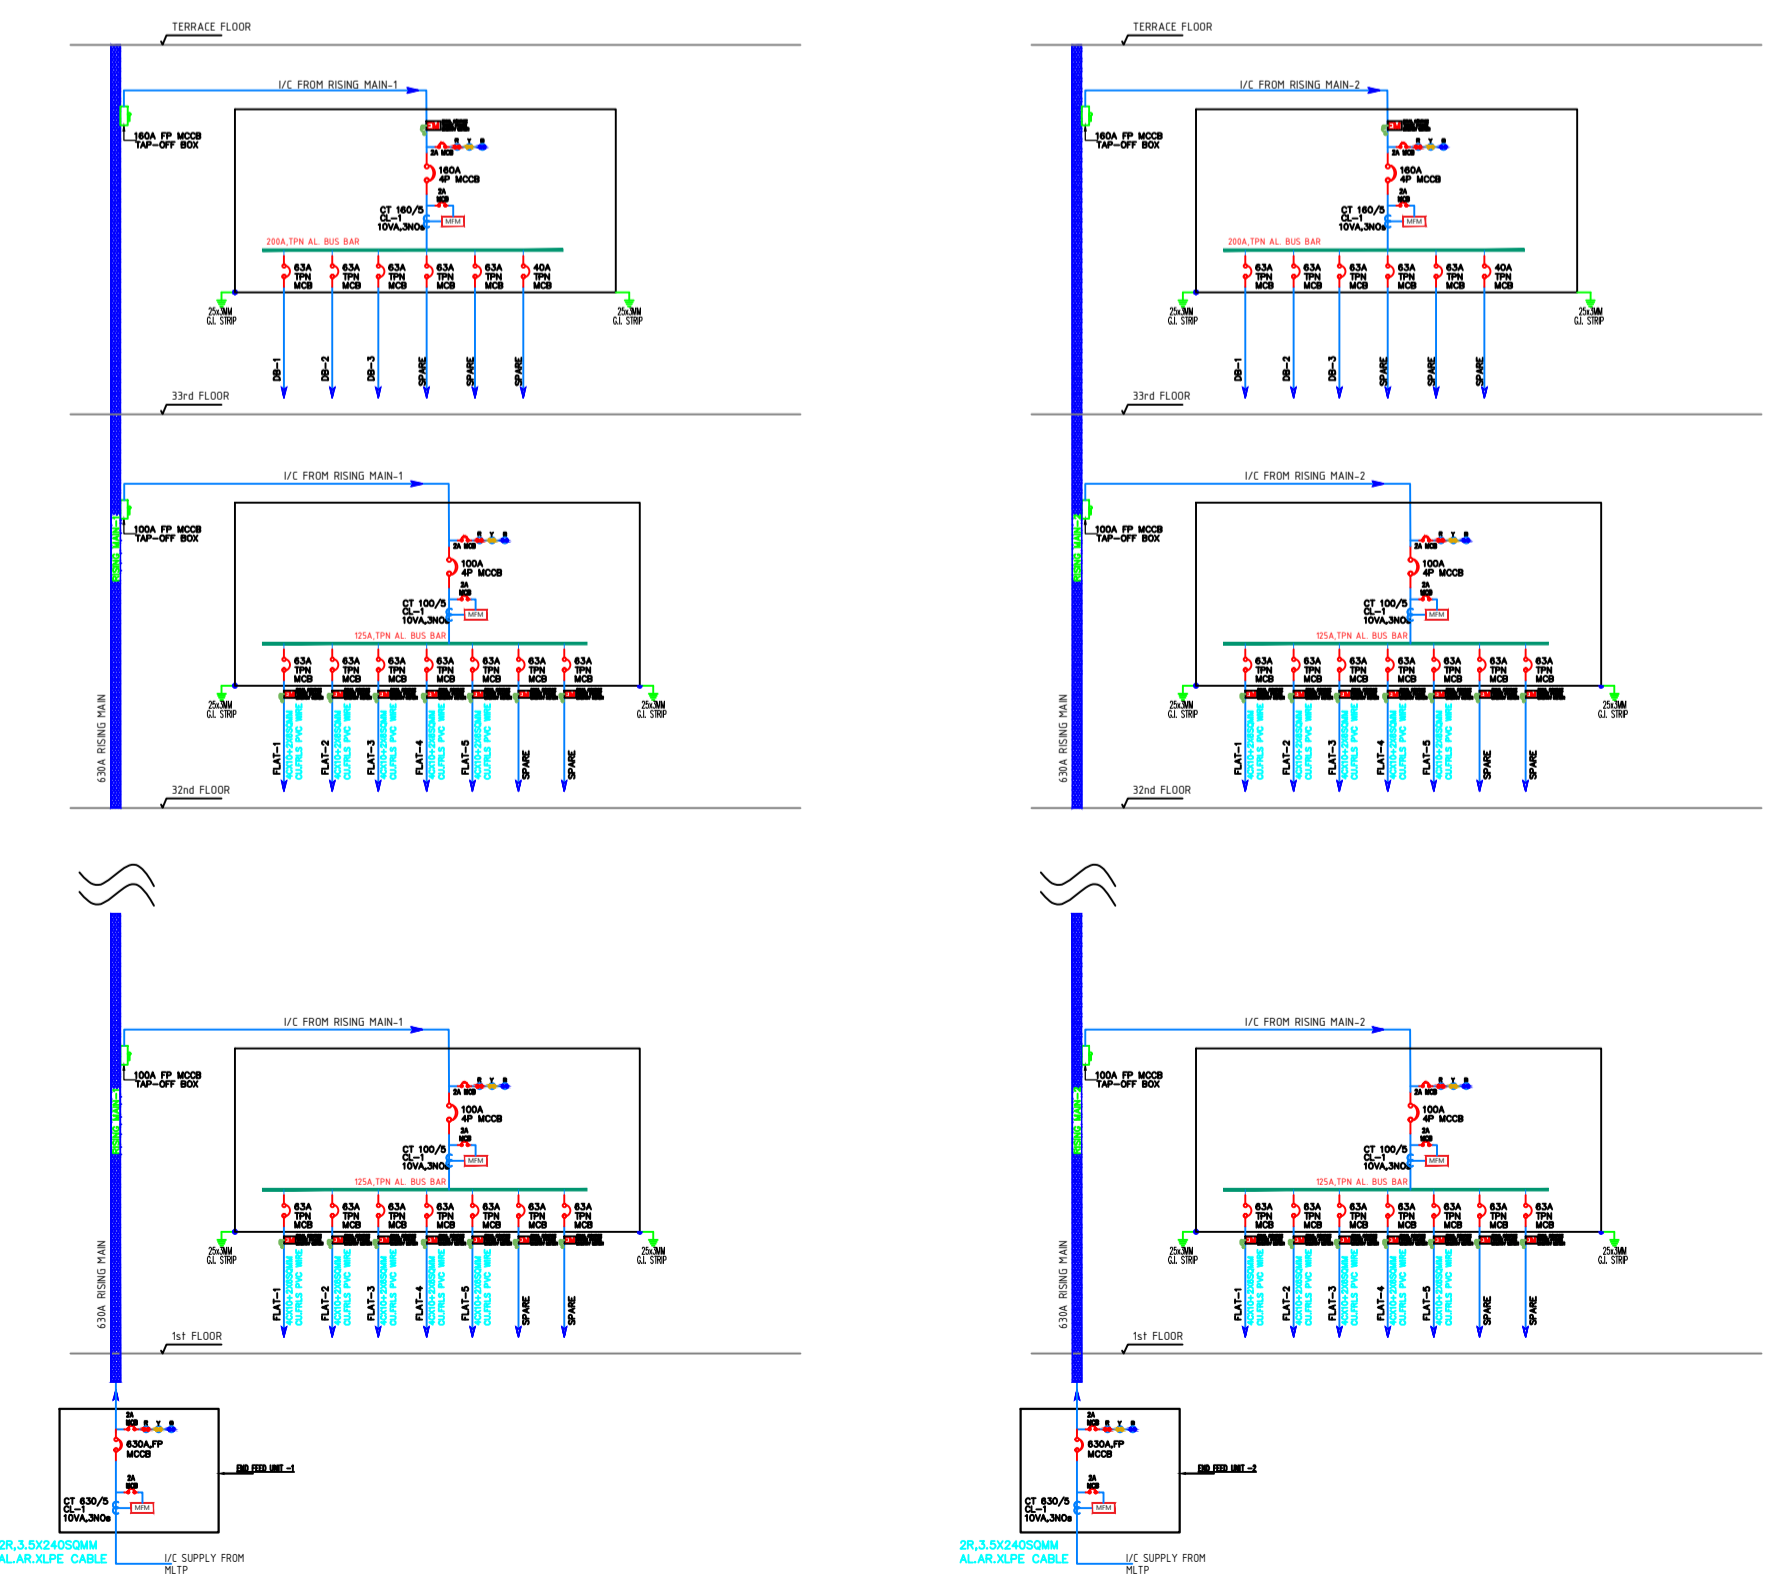

ARCHITECT'S SIGNATURE / STAMP :

OWNER SIGNATURE / STAMP :

PROJECT ARCHITECT:
Rajeev Aggarwal Architects
 #196, Chhargate Park
 New Delhi-110079
 Telephone : 2627676,2627472,
 FAX : 2627789
 e-mail : rajeev@rajeev.com
 web site : rajeevrajeev.com

STRUCTURE
NCC DESIGN INTERNATIONAL
 NCC CONSULTING STRUCTURAL ENGINEERS
 G-10, Sector-10, Connaught Place, New Delhi-110028
 Phone No. 41-266674,41-2719, 41-266678
 Fax No. 41-266674,41-2719, 41-266678
 E-mail : nccdesigninternational@gmail.com
 Web : www.nccdesigninternational.com

PROJECT LANDSCAPE CONSULTANTS
Greenbox Designs
 P-123, DLF City Phase 2
 Gurgaon
 Haryana, India

PROJECT TITLE
 REVISED Building Plans Of Group Housing Colony
 Area Measuring 27.48125 Acres
 (25.10 Acres Under Licence No.39 of 2013 Dated 04.06.2013
 and 2.38125 Acres Under
 Licence No. 85 of 2014 Dated 08.08.2014) in Sector-36-A,
 Gurgaon Manesar Urban Complex Being Developed by
 BLUEJAYS REALTECH PVT. LTD.
 Being Co-developed By
 (KRISUMI CORPORATION PVT. LTD.)

MEP CONSULTANT:
PDA Consultants
 MEP & Green Building Consultants
 REGD OFFICE:
 190, SECOND FLOOR, F.I.E
 PARPATGANJ INDUSTRIAL
 AREA, DELHI-110092, INDIA
 TEL. : +91-11-42408830/142408302
 E-MAIL : delhi@pdacounsultants.in

SHEET NAME
SINGLE LINE DIAGRAM

SCALE A0@ NTS	DATE 24.04.2023
DRAWN BY A.S.	CHECKED BY H.A.
SHEET NO PDA-197/SLD/EL-01	
DRAWING STATUS	